


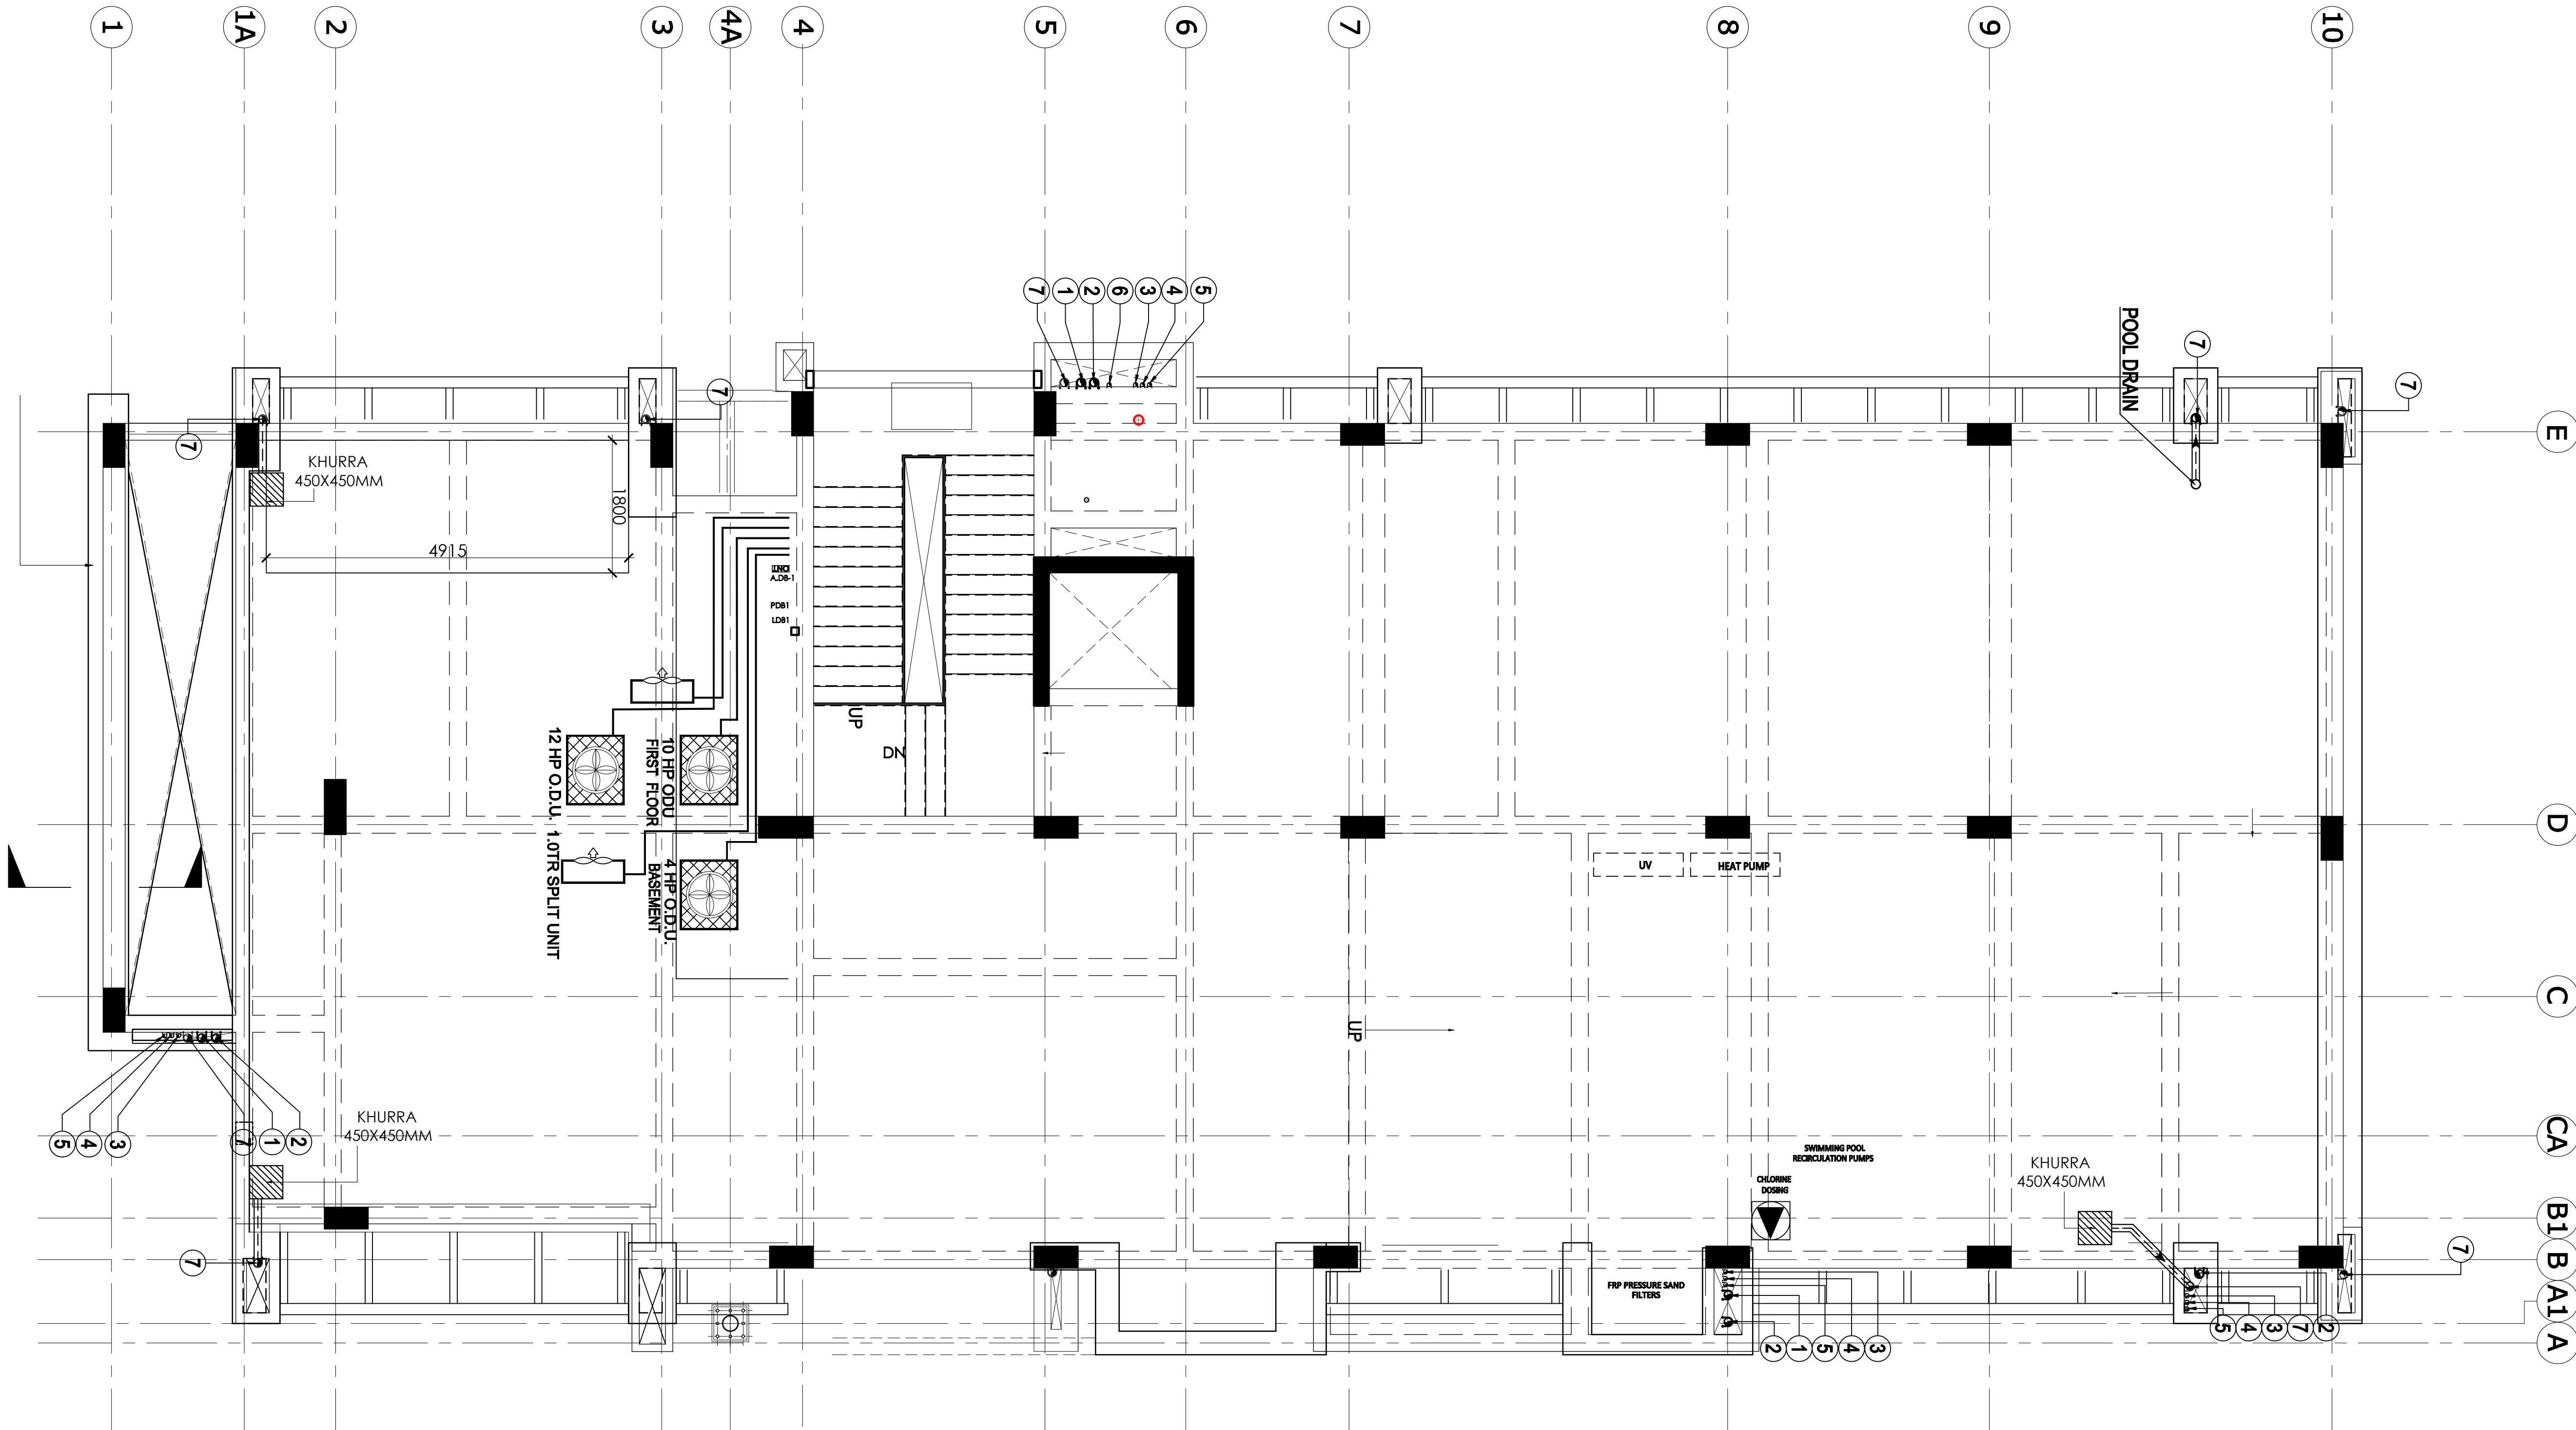

TERRACE FLOOR

NOTES :
This drawing is the property of M/s. SPACES ARCHITECTURE STUDIO and it shall not be used, reproduced or modified without written permission. The drawing shall not be scaled, only written dimensions shall be followed.
This drawing supercedes all previous drawings issued for the information contained in the drawing.
All discrepancies shall be brought to the notice of the architects before execution of the work.
Any modifications at site w/o prior written information to the Architect are the responsibility of the Owner.

CONSTRUCTION NOTES :
DETAIL SHOP DRAWINGS TO BE PROVIDED BY THE CONTRACTOR FOR APPROVAL PRIOR CASTING.
NO SLEEVE FOR KHURRA, REFER TO SECTION DETAILS

LEGENDS :

PLUMBING LEGEND :-	
SYMBOL	DESCRIPTION
①	110 OD SOIL PIPE
②	110 OD WASTE PIPE
③	900 VENT PIPE
④	DOMESTIC WATER SUPPLY DN TAKE
⑤	FLUSHING WATER SUPPLY DN TAKE
⑥	HOT WATER SUPPLY DN TAKE
⑦	HOT WATER RETURN PIPE
⑧	DOMESTIC WATER RISER PIPE
⑨	FLUSHING WATER RISER PIPE
⑩	110 OD RAIN WATER PIPE
⑪	RO WATER SUPPLY DN TAKE

PLUMBING LEGEND :-		
SYMBOL	DESCRIPTION	MATERIAL OF PIPE
●	FI-140MM OD PIPE SLEEVE	UPVC/HDEPE
+	FI-75MM OD PIPE SLEEVE	UPVC/HDEPE
●	FCO-140MM OD PIPE SLEEVE	UPVC/HDEPE

F.T.	FLOOR TRAP
F.C.O	FLOOR CLEAN OUT
F.D.	FLOOR DRAIN

REVISION NOTES :

No.	DETAIL	DESCRIPTION
1	R2	TOILET DESIGN REVISED

PROJECT:
SOUTH AFRICA HIGH COMMISSION

PROJECT OWNER/ DEVELOPER:
INTERNATIONAL RELATIONS & COOPERATION, REPUBLIC OF SOUTH AFRICA

ARCHITECT:
Spaces Architecture Studio
V-12/23 DLF-3, Gurugram.
Ph.: 0124-4734320
e-mail: contact@studiosas.in
https://www.studiosas.in

CONSULTANT:

PURPOSE OF DWG:
☐ Issued for Construction
☒ Issued for Tender
☐ Issued for Information

DRAWING TITLE:
TERRACE FLOOR COORDINATED STRUCTURE AND PLUMBING LAYOUT

DISCIPLINE : ARCHITECTURE **DATE:** 16.10.25
DRAWING NO: SAS/SA/STAGE4/A (RES.)10.10 **REV:** N

