


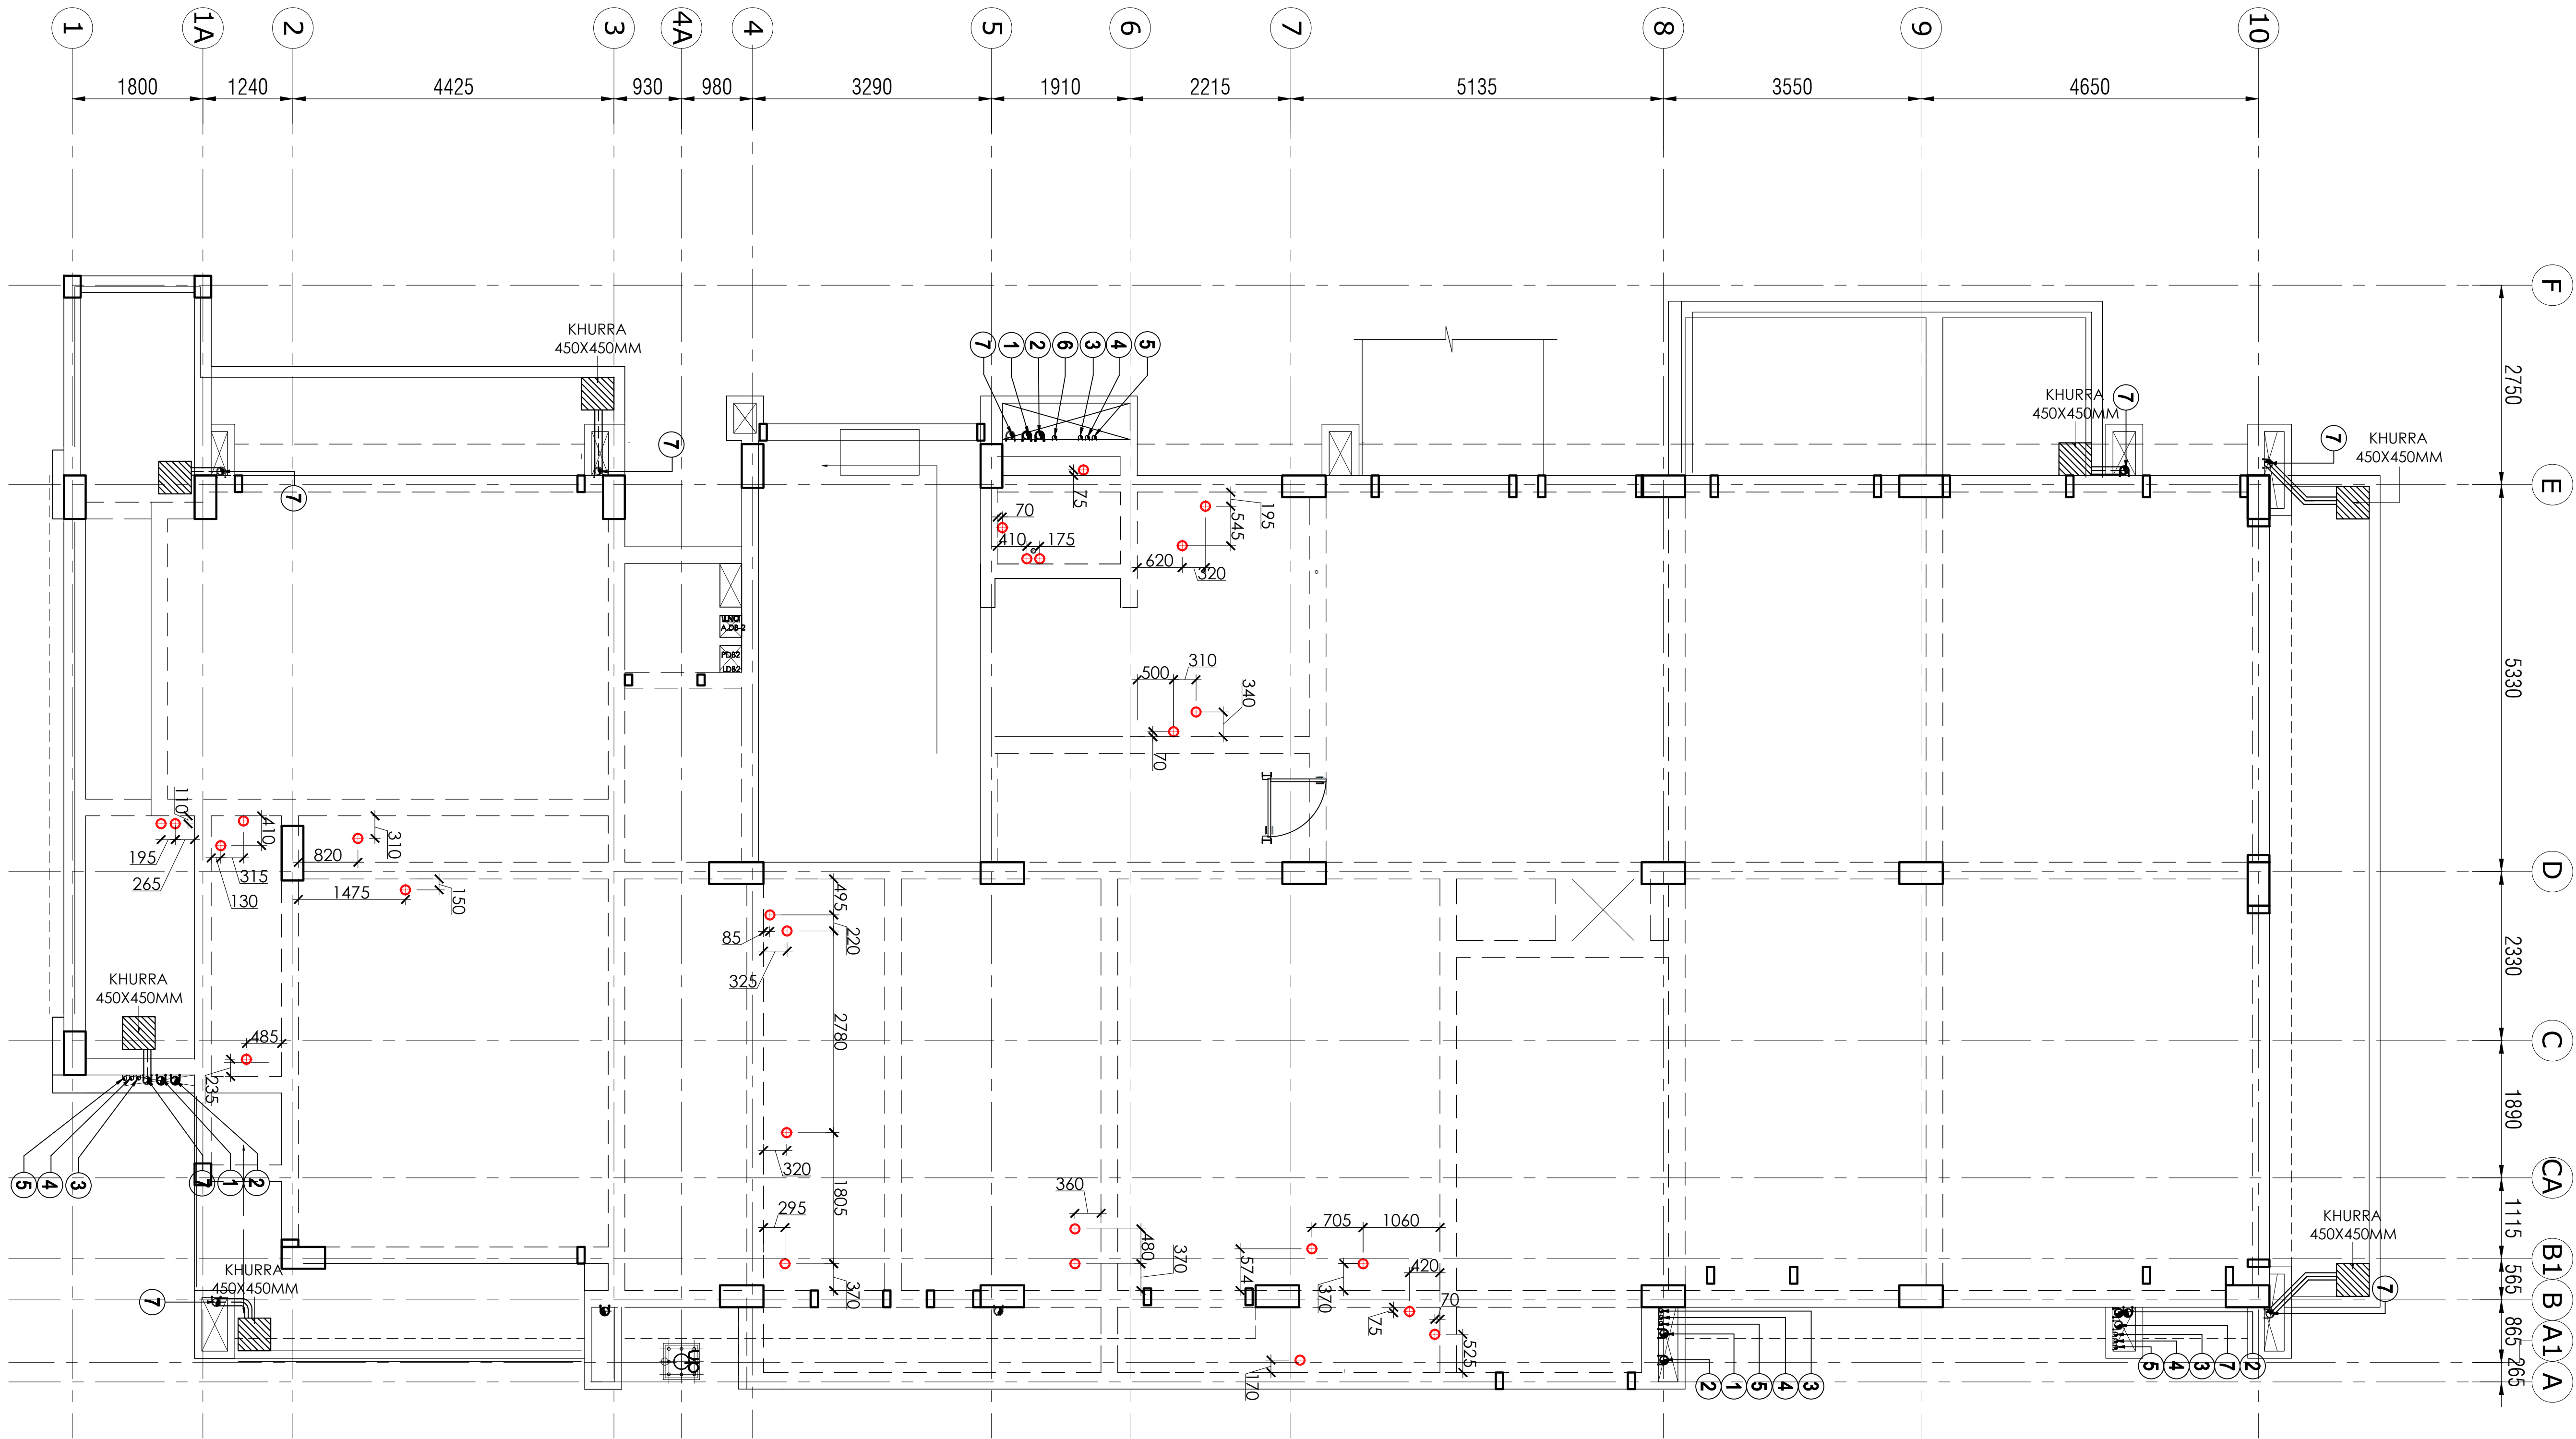

FIRST FLOOR

**NOTES :**  
This drawing is the property of M/s. SPACES ARCHITECTURE STUDIO and it shall not be used, reproduced or modified without written permission. The drawing shall not be scaled, only written dimensions shall be followed.  
This drawing supercedes all previous drawings issued for the information contained in the drawing.  
All discrepancies shall be brought to the notice of the architects before execution of the work.  
Any modifications at site w/o prior written information to the Architect are the responsibility of the Owner.

**CONSTRUCTION NOTES :**  
DETAIL SHOP DRAWINGS TO BE PROVIDED BY THE CONTRACTOR FOR APPROVAL PRIOR TO CONSTRUCTION.  
NO SLEEVE FOR KHURRA, REFER TO SECTION DETAILS

**LEGENDS :**

| PLUMBING LEGEND :- |                                |
|--------------------|--------------------------------|
| SYMBOL             | DESCRIPTION                    |
| ①                  | 110 OD SOIL PIPE               |
| ②                  | 110 OD WASTE PIPE              |
| ③                  | 900 VENT PIPE                  |
| ④                  | DOMESTIC WATER SUPPLY DN. TAKE |
| ⑤                  | FLUSHING WATER SUPPLY DN. TAKE |
| ⑥                  | HOT WATER SUPPLY DN. TAKE      |
| ⑦                  | HOT WATER RETURN PIPE          |
| ⑧                  | DOMESTIC WATER RISER PIPE      |
| ⑨                  | FLUSHING WATER RISER PIPE      |
| ⑩                  | 110 OD RAIN WATER PIPE         |
| ⑪                  | RO WATER SUPPLY DN. TAKE       |

| PLUMBING LEGEND :- |                          |                  |
|--------------------|--------------------------|------------------|
| SYMBOL             | DESCRIPTION              | MATERIAL OF PIPE |
| ●                  | FI-140MM OD PIPE SLEEVE  | uPVC/HDPE        |
| +                  | FI-75MM OD PIPE SLEEVE   | uPVC/HDPE        |
| ●                  | FCO-140MM OD PIPE SLEEVE | uPVC/HDPE        |

|       |                 |
|-------|-----------------|
| F.T.  | FLOOR TRAP      |
| F.C.O | FLOOR CLEAN OUT |
| F.D.  | FLOOR DRAIN     |

**REVISION NOTES :**

| No. | DETAIL | DESCRIPTION |
|-----|--------|-------------|
|     |        |             |
|     |        |             |
|     |        |             |
|     |        |             |
|     |        |             |

**PROJECT:**

SOUTH AFRICA HIGH COMMISSION

**PROJECT OWNER/ DEVELOPER:**

INTERNATIONAL RELATIONS & COOPERATION, REPUBLIC OF SOUTH AFRICA

**ARCHITECT:**

Spaces Architecture Studio  
V-12/23 DLF-3, Gurugram.  
Ph.: 0124-4734320  
e-mail: contact@studiosas.in  
<https://www.studiosas.in>

**CONSULTANT:**

**PURPOSE OF DWG:**

- ☐ Issued for Construction  
☒ Issued for Tender  
☐ Issued for Information

**DRAWING TITLE:**

FIRST FLOOR COORDINATED STRUCTURE AND PLUMBING LAYOUT

DISCIPLINE : ARCHITECTURE DATE: 16.10.25

**DRAWING NO:**  
SAS/SA/STAGE4/A  
(RES.)10.9

REV: N

