


MUMTY PLAN
SCALE - 1:100

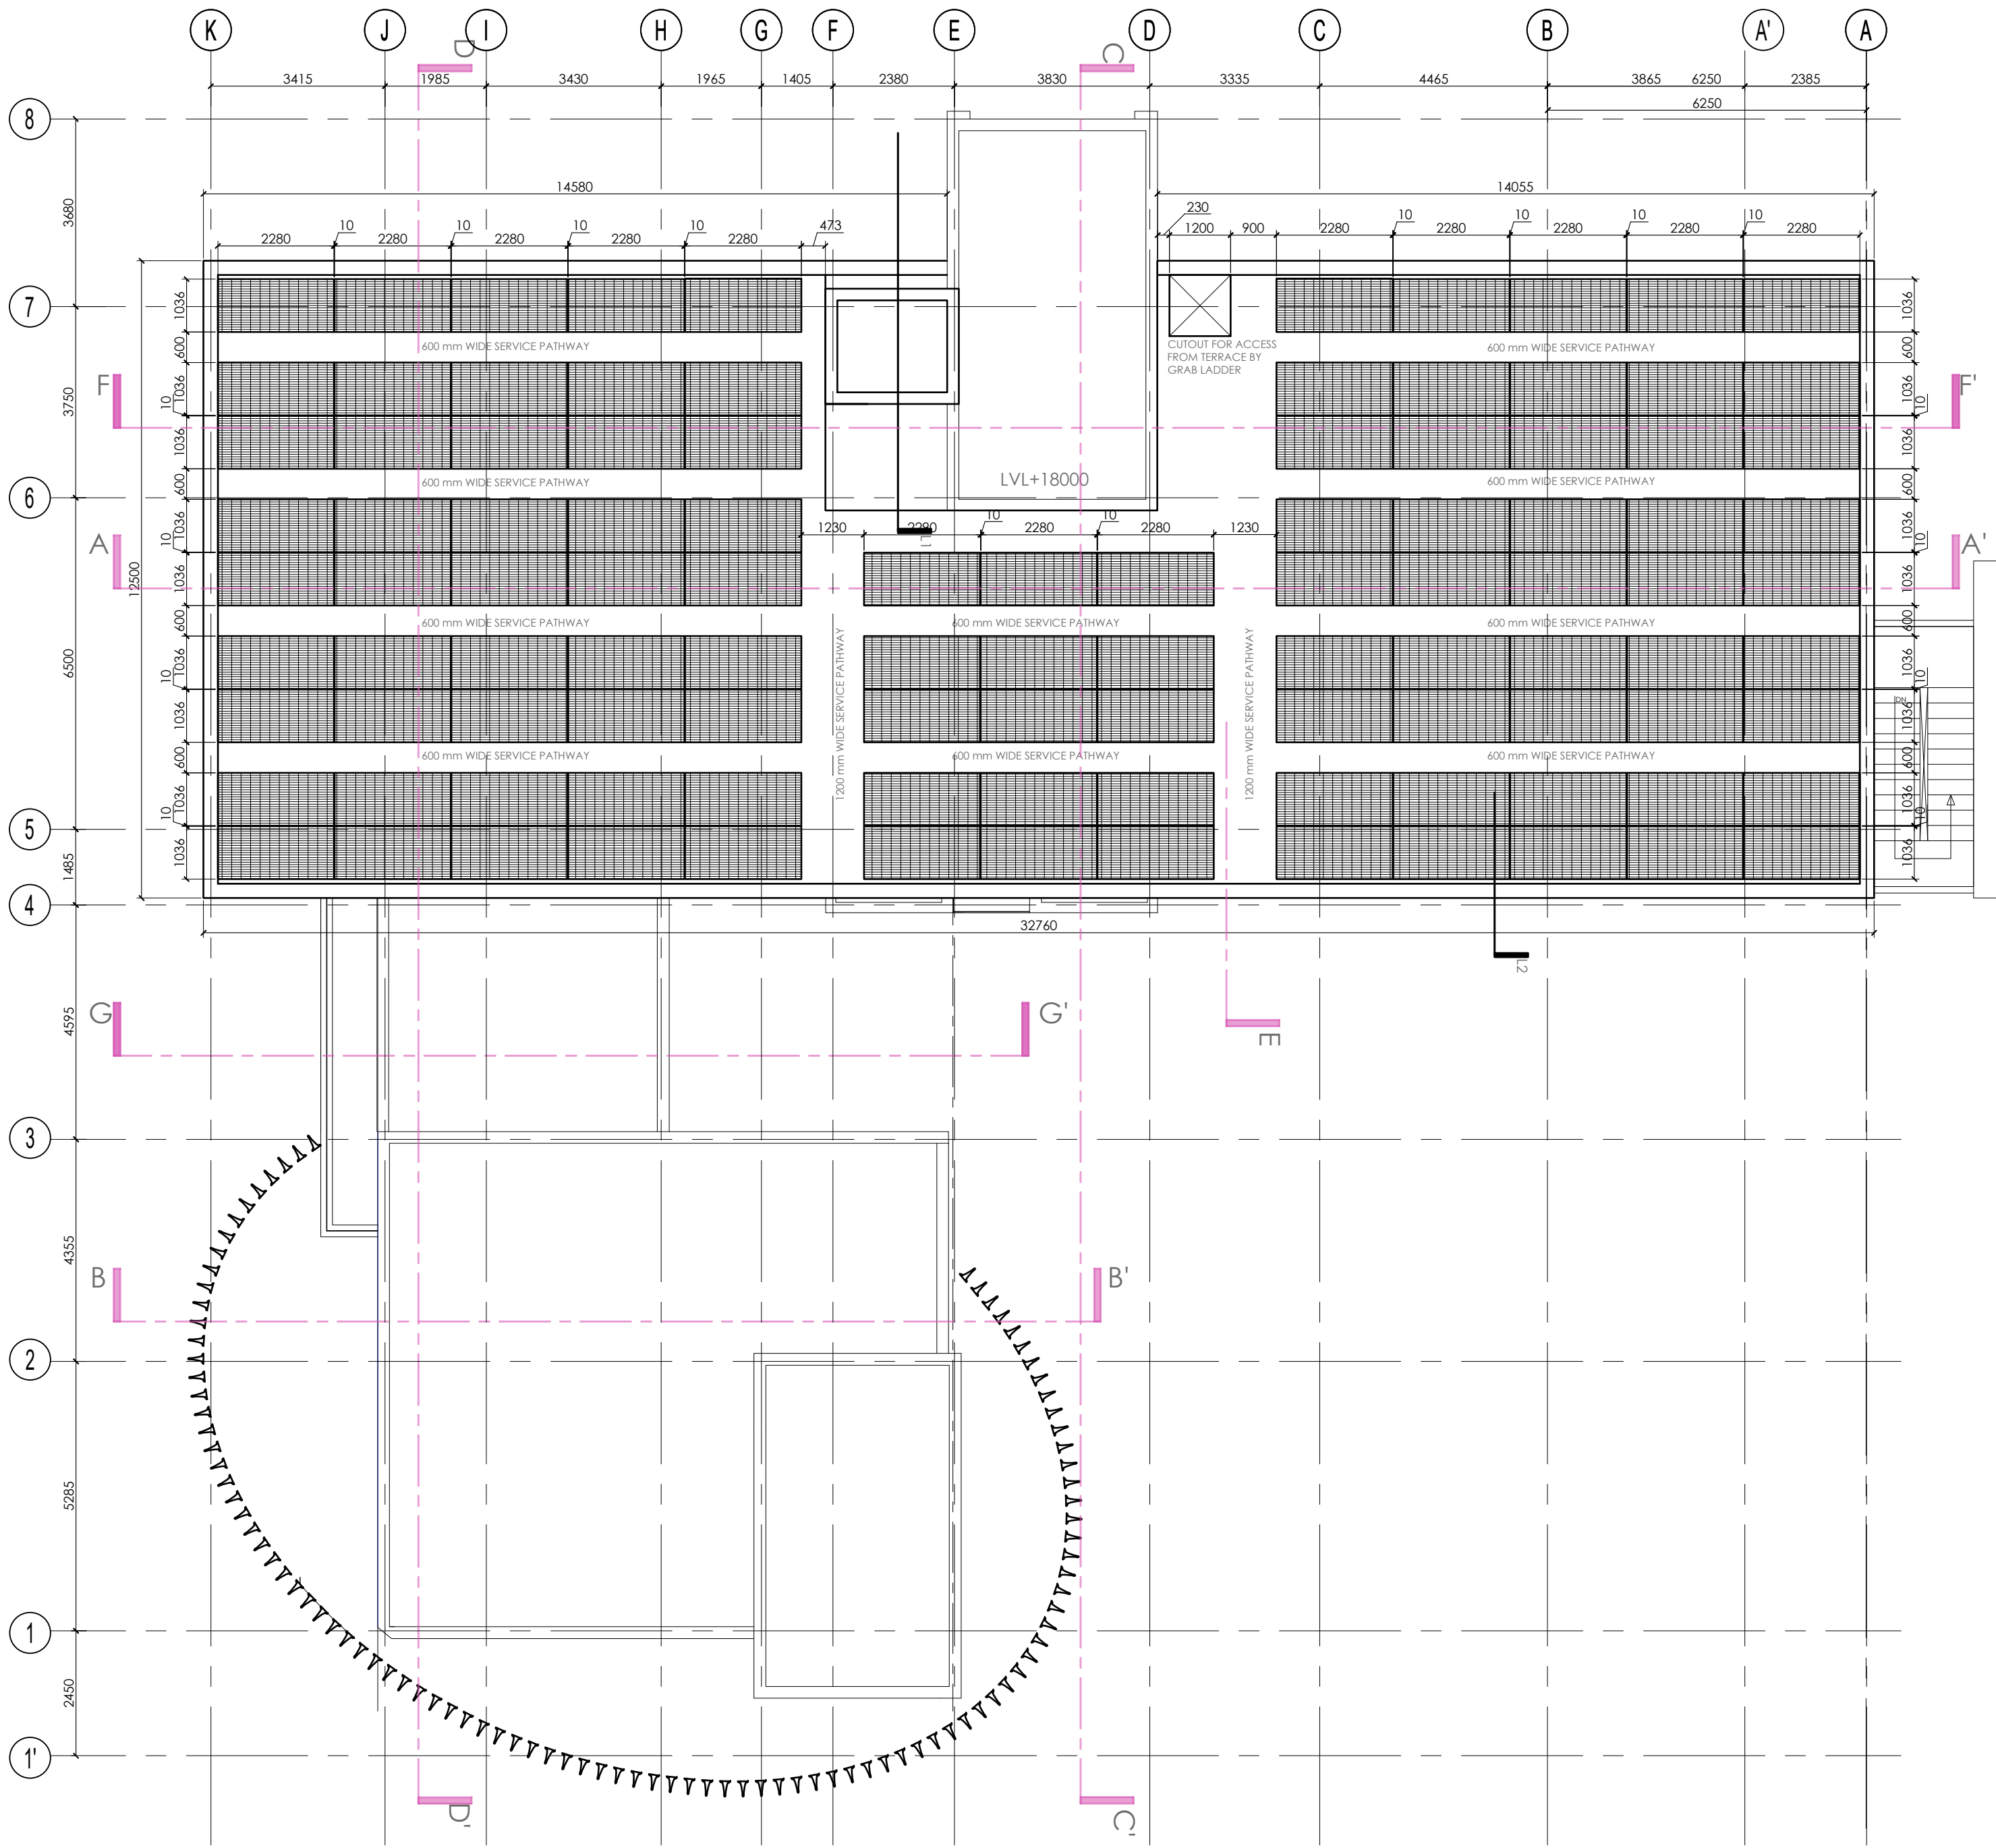

Door/Window Schedule

S.NO.	DOOR/WINDOW	SIZE	SILL LVL (MM)	LINTEL LVL (MM)
1	D1	900X2400	00	2400
2	D2	1200X2400	00	2400
3	D3	800X2400	00	2400
4	D4	1050X2400	00	2400
5	D5	1800X2400	00	2400
6	D6	2500X2400	00	2400
7	D1F	965X2400	00	2400
8	D2F,D2F'	1200X2400	00	2400
9	D4F,D4FW	1050X2400	00	2400
10	D5F	1500X2400	00	2400
11	DW4	1050X2400	00	2400
12	DW5	1500X2400	00	2400
13	DW6	1600X2400	00	2400
14	DW7	1900X2400	00	2400
15	DW7'	1900X2600	00	2750
15	SD1,SD1'	6630X2400	00	2400
16	SD2	2800X2400	00	2400
17	SD3	2330X2400	00	2400
18	SD4	2250X2400	00	2400
19	SD5	3000X2400	00	2400
20	W1	600X2250	150	2400
21	W2	600X1150	1250	2400
23	W3	430X2250	150	2400
24	W4	1670X2250	150	2400
25	W5	1700X600	500	1100
26	W5A	1700X1400	1000	2400
27	W6	2975X600	1800	2400
28	W7	1400X450	2100	2550
29	S	1220X2200	0	2200
30	FW1,FW1B	3000X2600	150	2750
31	FW1A	3000X1400	1000	2400
32	FW2	1200X2250	150	2400
33	FW3	2400X2600	150	2750
34	FW4,FW4,FW4'	13100X2600	150	
35	FW5	8000X2600	150	
36	FW6	4000X2250	150	2400
37	FW7,FW7'	1900X2250	150	2400
38	FW8	3700X2250	150	2400
39	FW9,FW9'	5670X2600	150	
40	FW10	2825X2250	150	2400
41	FW11	1050X2250	150	2400
42	FW12	3230X6600		
43	FW13	3500X17000		
44	FW13'	2860X17000		
45	FW14	1790X2250	150	2400
45	FW15	2450X2250	150	2400

FIRE EXTINGUISHER

1		FIRE EXTINGUISHER(9 LTR)
2		FIRE EXTINGUISHER(4.5 LTR)
3		DCP FIRE EXTINGUISHER(6 LTR)

NOTES :

This drawing is the property of M/s. SPACES ARCHITECTURE STUDIO and it shall not be used, reproduced or modified without written permission. The drawing shall not be scaled, only written dimensions shall be followed.
This drawing supercedes all previous drawings issued for the information contained in the drawing.
All discrepancies shall be brought to the notice of the architects before execution of the work.
Any modifications at site w/o prior written information to the Architect are the responsibility of the Owner.

CONSTRUCTION NOTES :

- ALL OPENINGS SHALL HAVE A 100 MM RCC JAMB; REFER TO JAMB DETAILS.
- ALL OPENING SIZES PROVIDED ARE ROUGH OPENING SIZES

LEGENDS :

FIRE FIGHTING LEGEND :-

SYMBOL	DESCRIPTION
	SPRINKLER
	BRANCH PIPE
	FIRE SPRINKLER PIPE
	BUTTERFLY VALVE
	NON-RETURN VALVE
	AIR CUSHION TANK
	AIR RELEASE VALVE
	PRESSURE GAUGE
	FIRE EXIT
	PARALEPTIC FIRE EXIT
	2 HR FIRE RATED DOOR
	FIRE EXTINGUISHER

REVISION NOTES :

No.	DETAIL	DESCRIPTION

PROJECT:

SOUTH AFRICA HIGH
COMMISSION

PROJECT OWNER/
DEVELOPER:

INTERNATIONAL
RELATIONS &
COOPERATION,
REPUBLIC OF SOUTH
AFRICA

ARCHITECT:

Spaces Architecture Studio
V-12/23 DLF-3, Gurugram.
Ph.: 0124-4734320
e-mail: contact@studiosas.in
https://www.studiosas.in

CONSULTANT:

PURPOSE OF DWG:

- ☐ Issued for Tender
- ☐ Issued for Construction
- ☐ Issued for Review
- ☐ Issued for Information

DRAWING TITLE:

Solar Framing/Mumty
Floor Plan

DISCIPLINE : ARCHITECTURE 16.10.25

DRAWING NO: SAS/SA/STAGE4/A
(CH)2.7

REV:

N

